



S:\Further North - PAA\3300 Design\3300.5 Technical\01-Drawing Production\CADD Drawings\R-201_R-202.dwg Plot Date: 18 August, 2013 - 3:44 PM

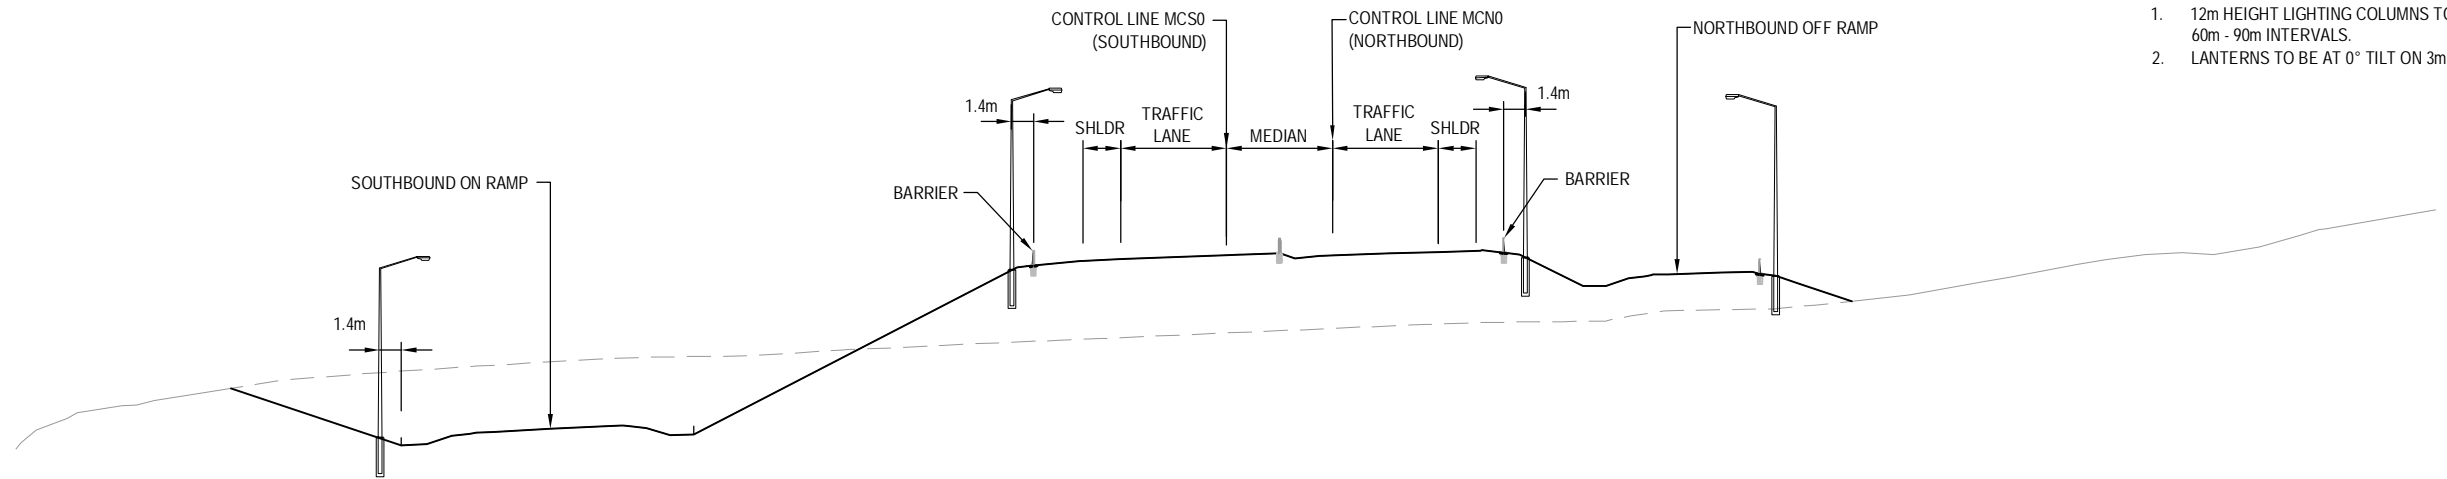

NOTES


1. 12m HEIGHT LIGHTING COLUMNS TO BE INSTALLED AT 60m - 90m INTERVALS.
2. LANTERNS TO BE AT 0° TILT ON 3m - 4m OUTREACH.

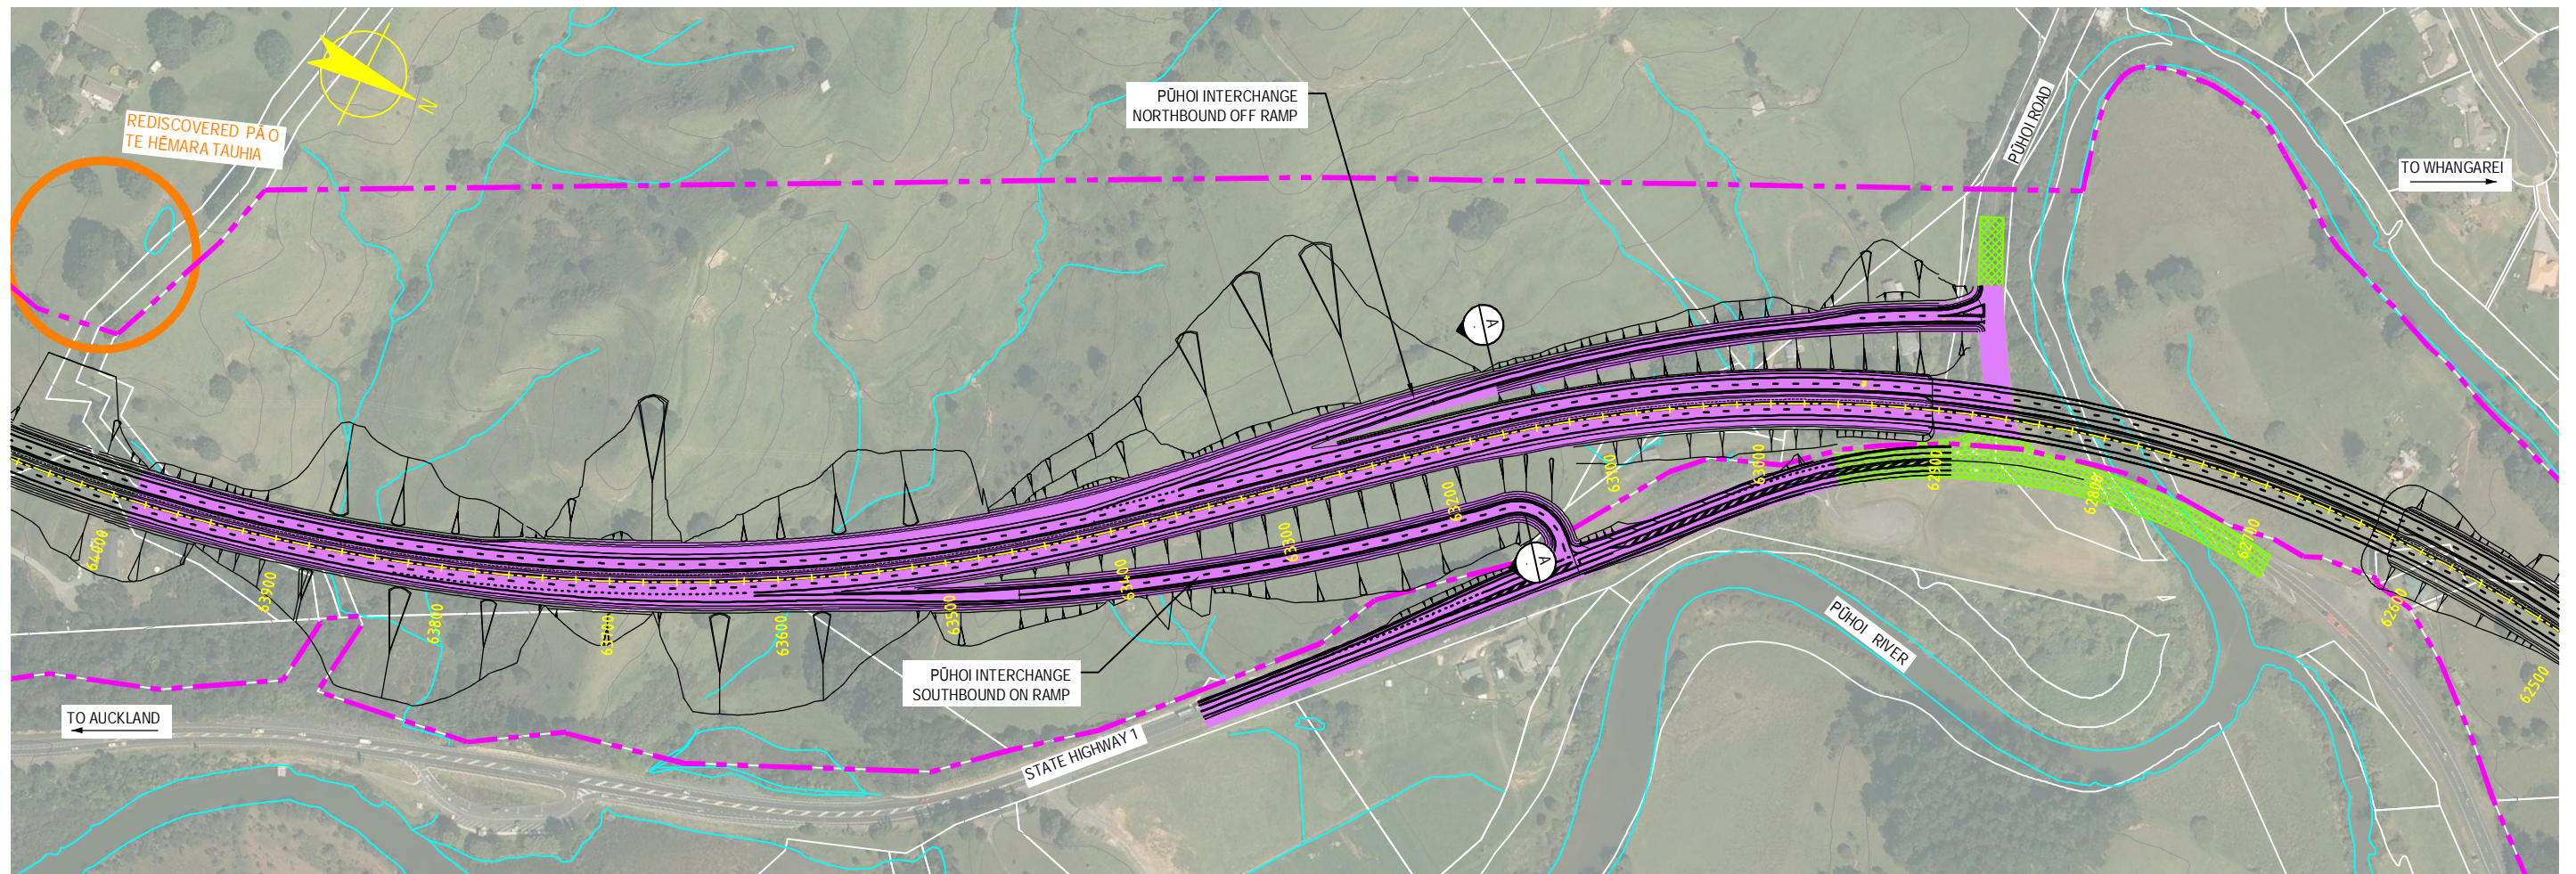

STREET LIGHTING PLAN
SCALE 1:4000 @ A3 SIZE

KEY

- EXISTING ROAD LIGHTING TO BE RETAINED
- PROPOSED AREA OF ROAD LIGHTING

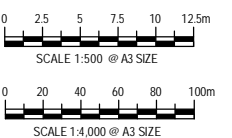

AMD	DATE	DESIGN REVIEW	REVD D. MGR	APPD A. MGR	PURPOSE OF ISSUE / AMENDMENT
0	30/08/13	RET	MRH	TI	ISSUE FOR NOR / CONSENT



DISCLAIMER

The information shown on this drawing is solely for the purposes of supporting RMA applications for statutory approvals. All information shown is subject to review for compliance with approved consents and the outcomes of final design.

ARA TŪHONO - PŪHOI TO WELLSFORD PŪHOI TO WARKWORTH - FOR RMA APPROVALS

DRAWN: SP / AN	DRAFTING CHECK: IH	REVIEWED DISCIPLINE MANAGER: MRH	APPROVED ALLIANCE MANAGER: TI
DESIGNED: IH	DESIGN REVIEW: RET		


ROAD LIGHTING PLAN - SHEET 1 OF 2 PŪHOI INTERCHANGE PLAN AND TYPICAL SECTION

SCALE: AS SHOWN	CONTRACT No: PA3748	DRAWING No: R-201	AMDT: 0
-----------------	---------------------	-------------------	---------


S:\Further North - PAA\300 Design\300.5 Technical\01-Drawing Production\CAAD\Drawings\R-201_R-202.dwg Plot Date: 18 August, 2013 - 3:44 PM

NOTES

1. 12m HEIGHT LIGHTING COLUMNS TO BE INSTALLED AT 60m INTERVALS.
2. LANTERNS TO BE AT 0° TILT ON 3m - 4m OUTREACH.

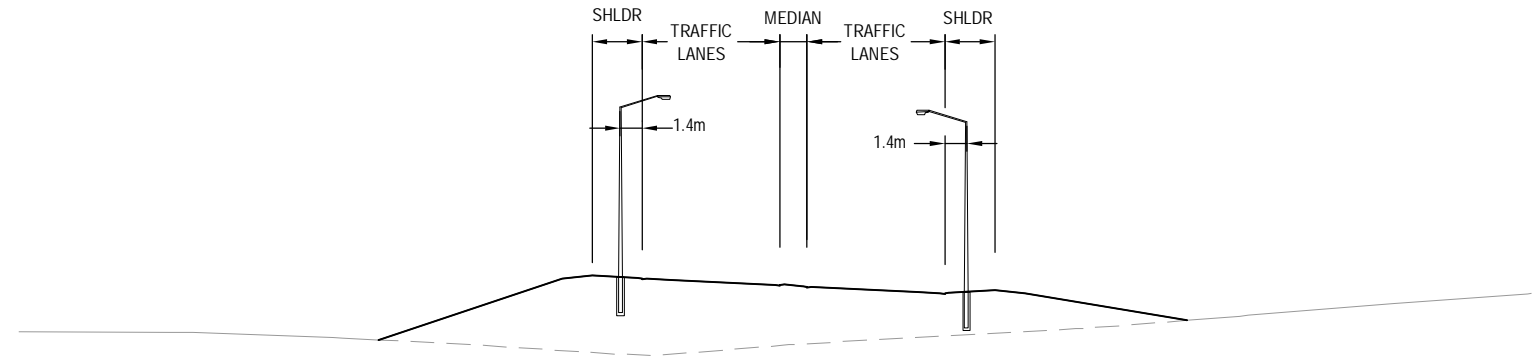


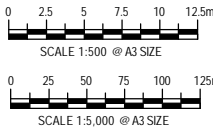
TYPICAL SECTION B-B
SCALE 1:500 @ A3 SIZE

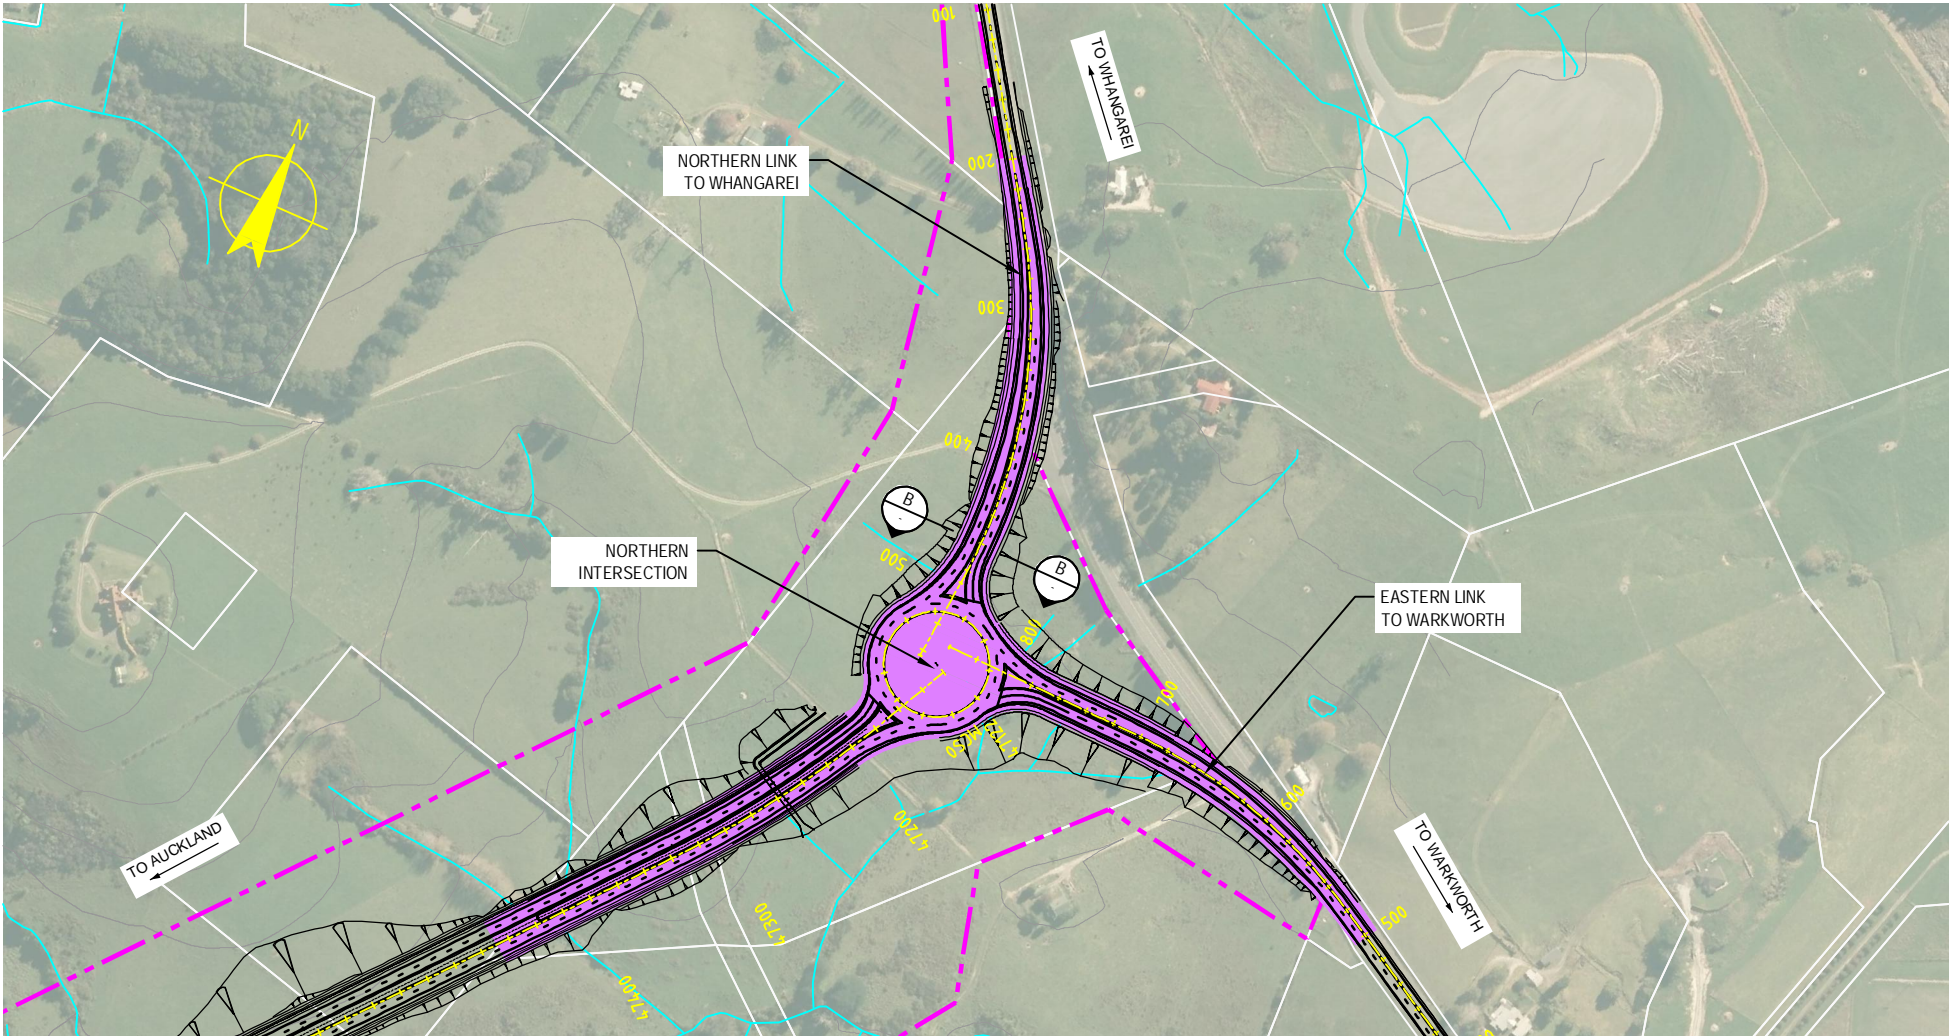

STREET LIGHTING PLAN
SCALE 1:5000 @ A3 SIZE

KEY

 PROPOSED AREA OF ROAD LIGHTING



0	30/08/13	RET	MRH	TI	ISSUE FOR NOR / CONSENT	
AMD	DATE	DESIGN REVIEW	REV'D D. MGR	APP'D A. MGR	PURPOSE OF ISSUE / AMENDMENT	



DISCLAIMER
The information shown on this drawing is solely for the purposes of supporting RMA applications for statutory approvals. All information shown is subject to review for compliance with approved consents and the outcomes of final design.

ARA TŪHONO - PŪHOI TO WELLSFORD			
PŪHOI TO WARKWORTH - FOR RMA APPROVALS			
DRAWN SP / AN	DRAFTING CHECK IH	REVIEWED DISCIPLINE MANAGER MRH	APPROVED ALLIANCE MANAGER TI
DESIGNED IH	DESIGN REVIEW RET		

ROAD LIGHTING PLAN - SHEET 2 OF 2 NORTHERN INTERSECTION PLAN AND TYPICAL SECTION			
SCALE AS SHOWN	CONTRACT No PA3748	DRAWING No R-202	AMDT 0